



Division of Administration and Finance
University Services

Press Release

FOR IMMEDIATE RELEASE

Ruth Hulett
Administrative Assistant
Phone: 713-743-3788
rmhulett@central.uh.edu

HEALTH AND BIOMEDICAL SCIENCE CENTER (OPTOMETRY)

Effective Monday, December 19, 2011 the front door of the Armistead Building on the Calhoun side of the Health and Biomedical Science Center will be closed – and until construction is complete sometime during the summer of 2012 – entry to the front entrance into the University Eye Institute lobby will be through:


- The existing fire door that is in the stairwell of Family Practice Service that opens onto Calhoun.
- From the Patient Parking Lot the double glass doors located near the maintenance trailer.
- From the Patient Parking Lot the sliding glass door near the elevator.

Please contact Frederick Maddox, Senior Project Manager, Facilities Planning & Construction, if you have questions related to this project fmaddox@central.uh.edu or by phone at 713-743-1245.

About the University of Houston

The University of Houston is a comprehensive national research institution serving the globally competitive Houston and Gulf Coast Region by providing world-class faculty, experiential learning and strategic industry partnerships. UH serves more than 38,500 students in the nation's fourth-largest city, located in the most ethnically and culturally diverse region of the country.

Tellepsen Site Logistics

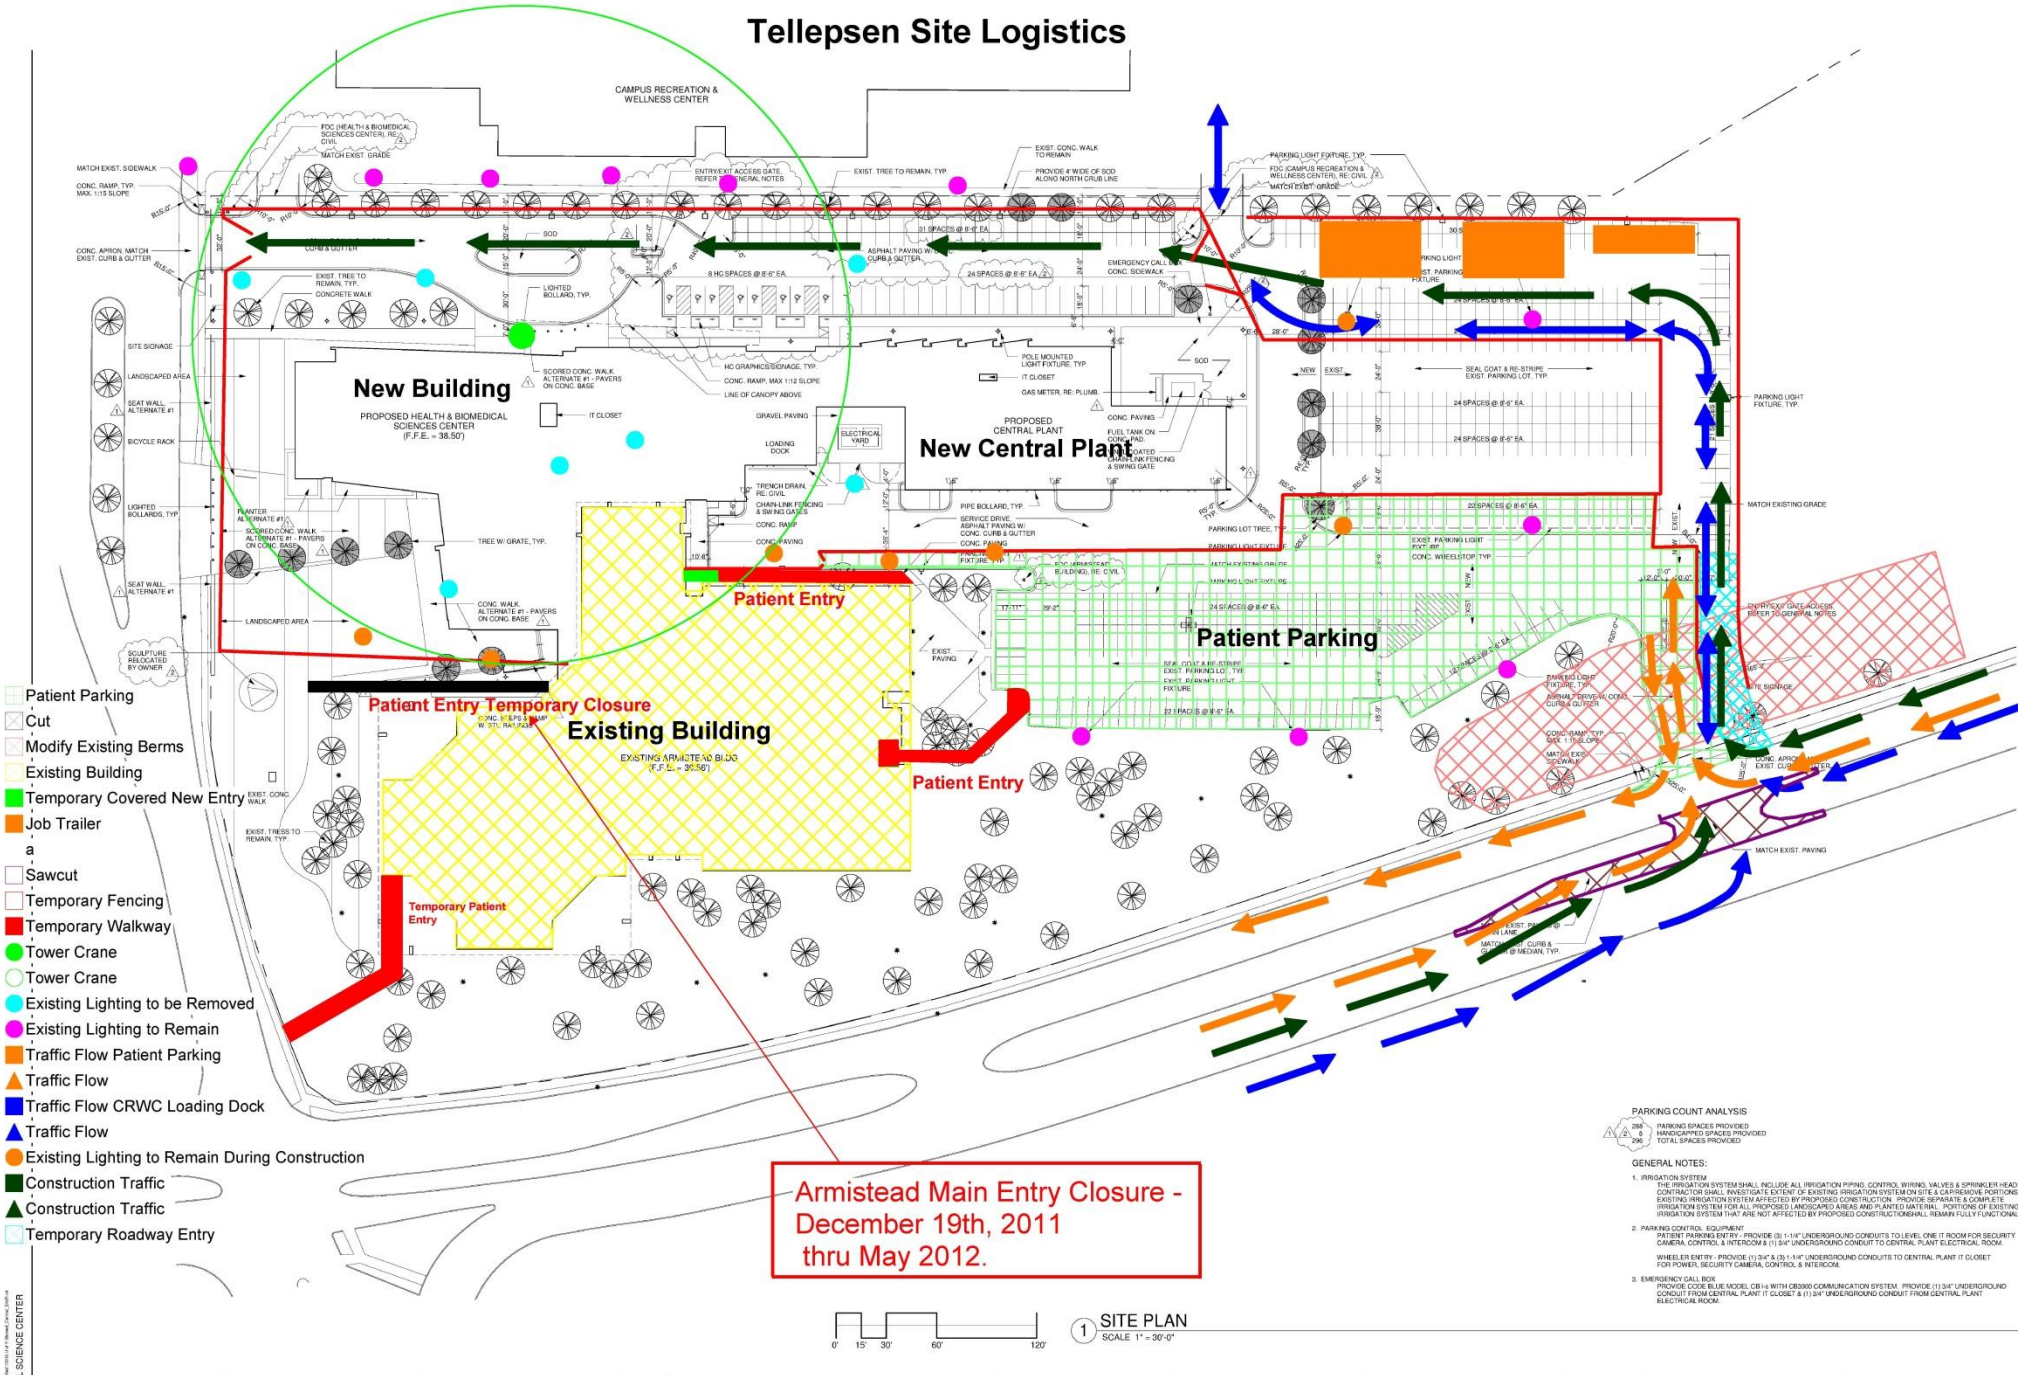

**Armistead Main Entry Closure -
 December 19th, 2011
 thru May 2012.**

PARKING COUNT ANALYSIS

PARKING SPACES PROVIDED
 HANDICAPPED SPACES PROVIDED
 TOTAL SPACES PROVIDED

GENERAL NOTES:

1. IRRIGATION SYSTEM
 THE IRRIGATION SYSTEM SHALL INCLUDE ALL IRRIGATION PIPING, CONTROL WIRING, VALVES & SPRINKLER HEADS. CONTRACTOR SHALL INVESTIGATE EXTENT OF EXISTING IRRIGATION SYSTEM ON SITE & CARRIAGEWAYS. PORTIONS OF EXISTING IRRIGATION SYSTEM AFFECTED BY PROPOSED CONSTRUCTION, PROVIDE SEPARATE & COMPLETE IRRIGATION SYSTEM FOR ALL PROPOSED LANDSCAPED AREAS AND PLANTED MATERIAL. PORTIONS OF EXISTING IRRIGATION SYSTEM THAT ARE NOT AFFECTED BY PROPOSED CONSTRUCTION SHALL REMAIN FULLY FUNCTIONAL.
2. PARKING CONTROL EQUIPMENT
 PATIENT PARKING ENTRY: PROVIDE (2) 1-1/4" UNDERGROUND CONDUITS TO LEVEL ONE (1) ROOM FOR SECURITY CAMERA CONTROL & INTERCOM & (1) 3/4" UNDERGROUND CONDUIT TO CENTRAL PLANT ELECTRICAL ROOM. WHEELER ENTRY: PROVIDE (1) 3/4" x 1/2" x 1/4" UNDERGROUND CONDUITS TO CENTRAL PLANT IT CLOSET FOR POWER SECURITY CAMERA CONTROL & INTERCOM.
3. EMERGENCY CALL BOX
 PROVIDE CODE BLUE MODEL CB-14 WITH CB3000 COMMUNICATION SYSTEM. PROVIDE (1) 3/4" UNDERGROUND CONDUIT FROM CENTRAL PLANT IT CLOSET & (1) 3/4" UNDERGROUND CONDUIT FROM CENTRAL PLANT ELECTRICAL ROOM.

0' 15' 30' 60' 120' **1 SITE PLAN**
 SCALE 1" = 30'-0"

<p>Equipment Collaborative</p> <p>8100 Washington Ave., Suite 200, Houston, TX 77057 Tel: 713.589.9797 Fax: 713.529.4112</p>	<p>DataCem Design Group, LLC</p> <p>3000 W. Sam Houston Pkwy. S., Suite 1000, Houston, TX 77062 Tel: 713.589.9797 Fax: 713.529.4112</p>	<p>Structures + Hayes Whaley, LLC</p> <p>10700 Richmond Ave., Suite 618, Houston, TX 77042 Tel: 713.866.1591 Fax: 713.866.0646</p>	<p>Kut & Associates, Inc.</p> <p>50 Waugh Dr., Suite 400, Houston, TX 77057 Tel: 713.524.2195 Fax: 713.524.3647</p>	<p>BAILEY ARCHITECTS</p> <p>3000 Richmond Ave., Suite 600, Houston, TX 77058 Tel: 713.875.8789 Fax: 713.875.2620</p>	<p>Shepley Bulfinch</p> <p>3000 Richmond Ave., Suite 600, Houston, TX 77058 Tel: 713.327.5888 Fax: 630.201.7188</p>	<p>Asakura Robinson Company, LLC</p> <p>3000 Richmond Ave., Suite 600, Houston, TX 77058 Tel: 713.327.5888 Fax: 630.201.7188</p>	<p>ES&C Engineers & Consultants, Inc.</p> <p>1010 Lander, Suite 600, Houston, TX 77028 Tel: 713.580.8800 Fax: 713.580.8888</p>	<p>UNIVERSITY OF HOUSTON SYSTEM</p> <p>UNIVERSITY OF HOUSTON HEALTH AND BIOMEDICAL SCIENCE CENTER</p>	<p>GMP CLARIFICATION NO.2</p> <p>NOVEMBER 08, 2010</p> <p>3539</p> <p>Author: _____ Checker: _____</p>	<p>SITE PLAN</p> <p>A1.11</p>
--	---	--	---	--	---	--	--	---	--	---